


*14' 10" front setback.*



01562  
14.2.2017

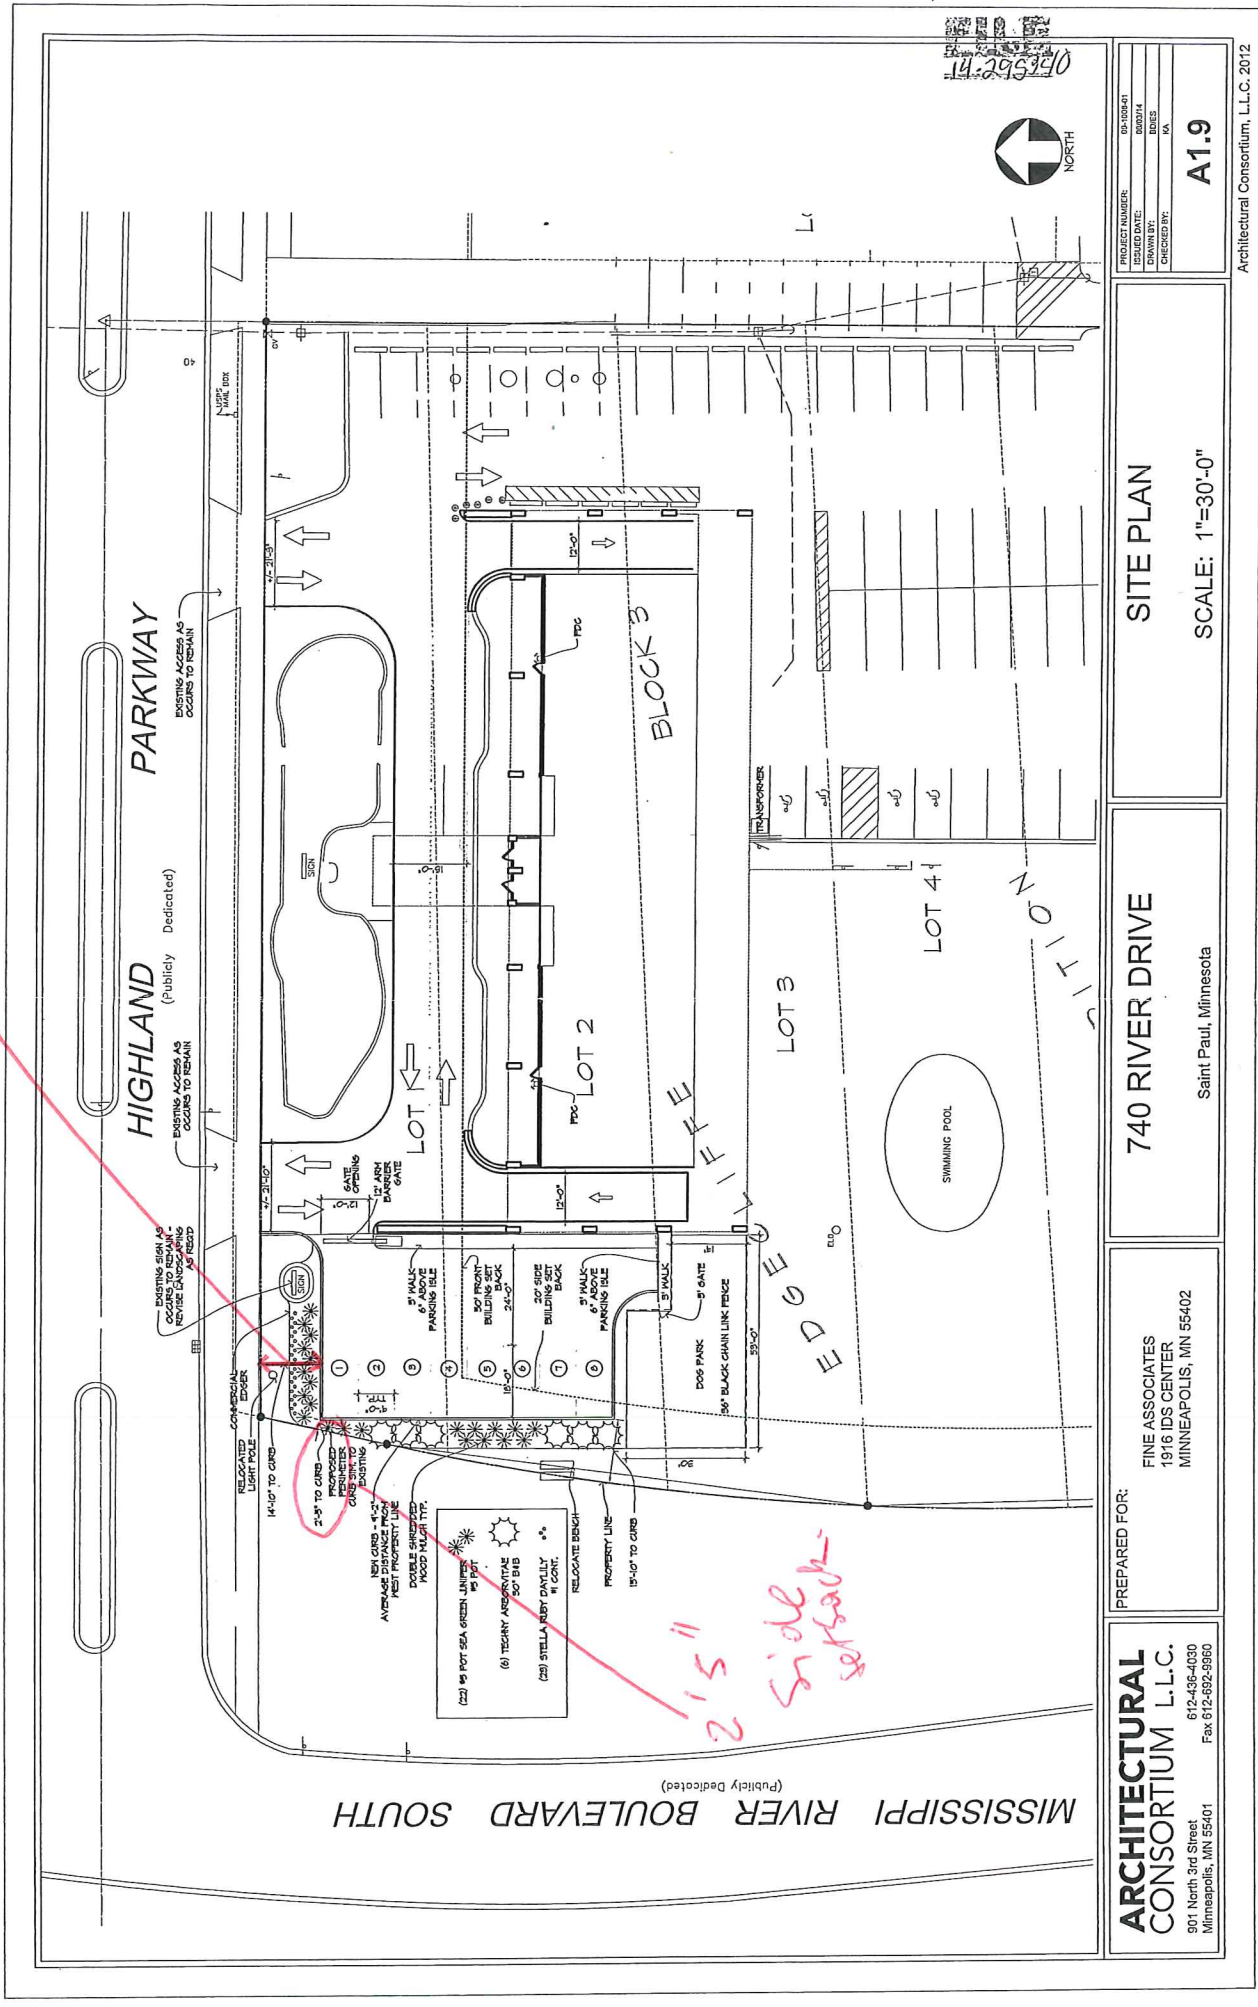

PROJECT NUMBER:	DP-1008-01
ISSUED DATE:	08/02/14
DRAWN BY:	BDES
CHECKED BY:	KA
<b>A1.9</b>	

**SITE PLAN**

SCALE: 1"=30'-0"

**740 RIVER DRIVE**

Saint Paul, Minnesota

PREPARED FOR:

FINE ASSOCIATES  
1916 IDS CENTER  
MINNEAPOLIS, MN 55402

**ARCHITECTURAL CONSORTIUM L.L.C.**

901 North 3rd Street  
Minneapolis, MN 55401  
612-436-4030  
Fax 612-692-9980